
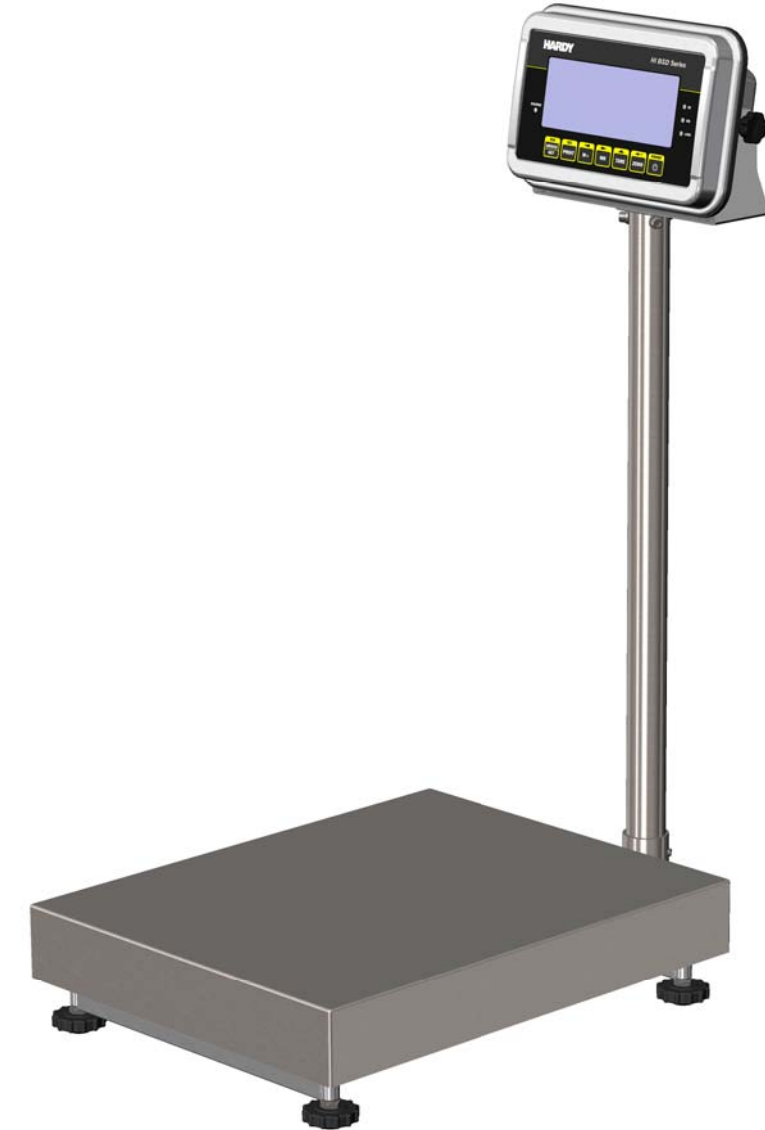


MODEL NUMBER	CAPACITY LBS [KG]	FRAME CONSTRUCTION
HIBSD-16PS-30KG	66 [30]	PAINTED STEEL
HIBSD-16PS-60KG	130 [60]	PAINTED STEEL
HIBSD-16PS-150KG	330 [150]	PAINTED STEEL
HIBSD-16SS-30KG	66 [30]	STAINLESS STEEL
HIBSD-16SS-60KG	130 [60]	STAINLESS STEEL
HIBSD-16SS-150KG	330 [150]	STAINLESS STEEL

REV.	ECO/DDC	DESCRIPTION	DATE	DRAFT	CHECK	APVD
A	----	RELEASED.	01-19-22	V.J.C.	J.M.	V.J.C.

 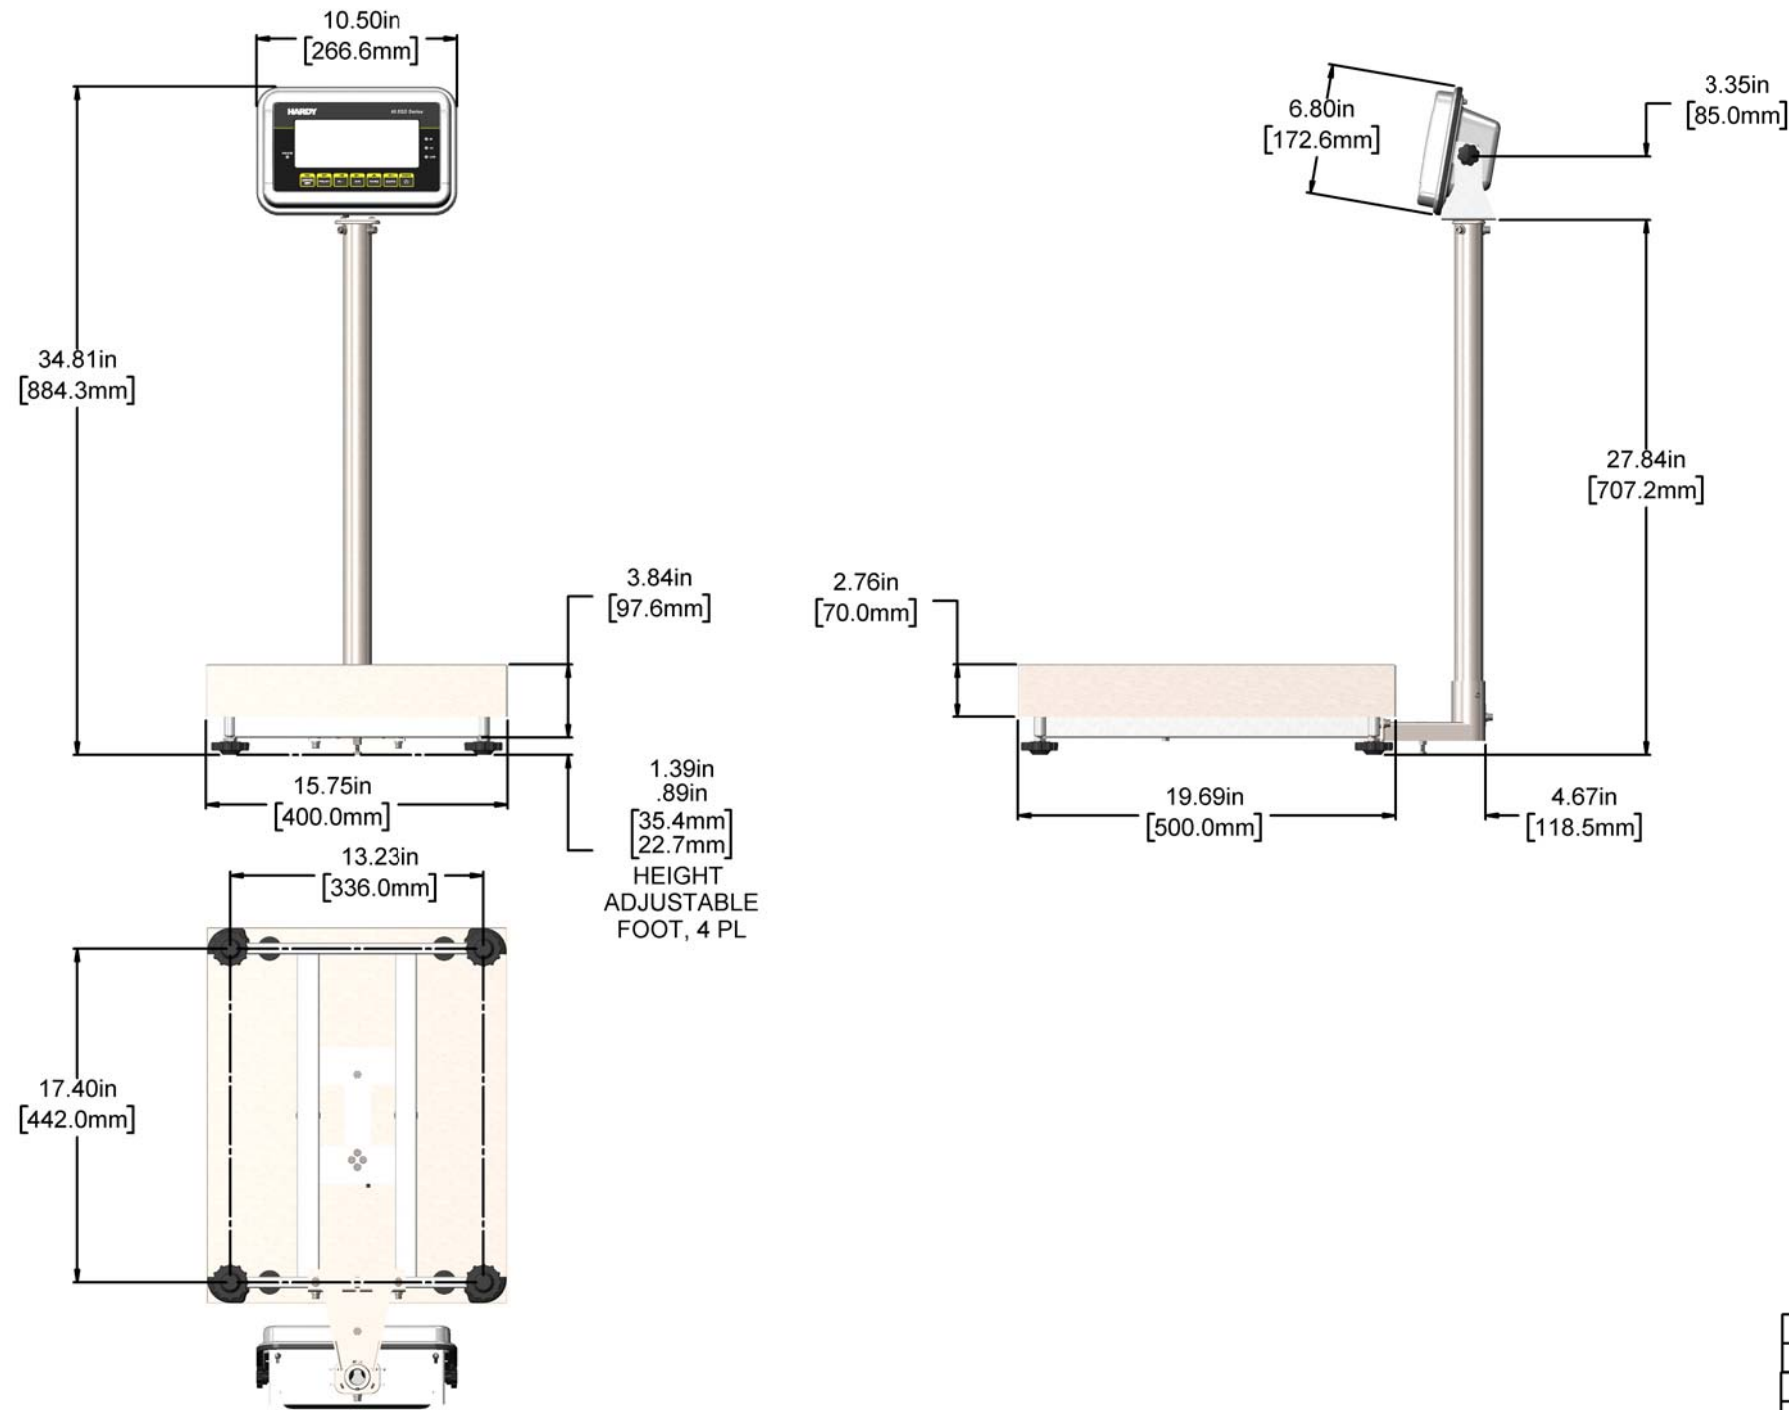


2. THIS DRAWING ONLY SHOWS THE AVAILABLE CAPACITIES AND GENERAL DIMENSIONS FOR THE HI BSD SERIES INSTRUMENTS. SEE HARDY PROCESS SOLUTIONS WEB SITE FOR INSTRUMENT SPECIFIC APPLICATION SOFTWARE VARIANTS.

1. SEE HARDY PROCESS SOLUTIONS WEB SITE FOR ADDITIONAL INFORMATION.

NOTES: UNLESS OTHERWISE SPECIFIED

PROPRIETARY NOTICE
ALL DATA AND INFORMATION CONTAINED IN OR DISCLOSED BY THIS DOCUMENT IS CONFIDENTIAL AND PROPRIETARY INFORMATION OF HARDY PROCESS SOLUTIONS AND ALL RIGHTS THEREIN ARE EXPRESSLY RESERVED. BY ACCEPTING THIS MATERIAL THE RECIPIENT AGREES THAT THIS MATERIAL AND THE INFORMATION CONTAINED THEREIN IS HELD IN CONFIDENCE AND IN TRUST AND SHALL NOT BE USED, COPIED, REPRODUCED IN WHOLE OR IN PART, NOR ITS CONTENTS REVEALED IN ANY MANNER TO OTHERS, EXCEPT TO MEET THE SPECIFIC PURPOSE FOR WHICH IT WAS DELIVERED.



ITEM	QTY	PART NUMBER	DESCRIPTION	COMMENTS														
		0588-0208	OUTLINE DRAWING, HI BSD SERIES BENCHTOP SCALE WITH DISPLAY, 16" X 20"	SEE NOTES														
PARTS LIST																		
UNLESS OTHERWISE SPECIFIED DIMENSIONS ARE IN INCHES TOLERANCES ARE: FRACTIONS: N/A DECIMALS: .XX = ±.03 .XXX = ±.010 ANGLES ±0°, 30'			<table border="1"> <tr> <th colspan="2">CONTRACT NO.</th> </tr> <tr> <th colspan="2">APPROVALS</th> </tr> <tr> <td>DRAWN V. CHULA</td> <td>DATE 01-19-22</td> </tr> <tr> <td>CHECKED J. MOEN</td> <td>DATE 01-19-22</td> </tr> <tr> <td>APPROVED V. CHULA</td> <td>DATE 01-19-22</td> </tr> <tr> <td>ISSUED V. CHULA</td> <td>DATE 01-19-22</td> </tr> <tr> <td>PRODUCTION</td> <td>DATE</td> </tr> </table>		CONTRACT NO.		APPROVALS		DRAWN V. CHULA	DATE 01-19-22	CHECKED J. MOEN	DATE 01-19-22	APPROVED V. CHULA	DATE 01-19-22	ISSUED V. CHULA	DATE 01-19-22	PRODUCTION	DATE
CONTRACT NO.																		
APPROVALS																		
DRAWN V. CHULA	DATE 01-19-22																	
CHECKED J. MOEN	DATE 01-19-22																	
APPROVED V. CHULA	DATE 01-19-22																	
ISSUED V. CHULA	DATE 01-19-22																	
PRODUCTION	DATE																	
MATERIAL			HARDY PROCESS SOLUTIONS															
FINISH			TITLE OUTLINE DRAWING, HI BSD SERIES BENCHTOP SCALE WITH DISPLAY, 16" X 20"															
DO NOT SCALE DRAWING			SIZE D	FSCM 21316														
			DRAWING NO. 0588-0209	REV. A														
			FILE NAME: 0588-0209A1.SLDDRW	SCALE: NONE														
			SHEET 1	OF 1														