


DIMENSION TABLE

MODEL NUMBER	CAPACITY KG [LBS]	WIDTH IN [MM]	HEIGHT IN [MM]	FOOTPRINT IN [MM]	REPLACEMENT LOAD SENSOR
HIBSX-12SS-SS6-5KG	5 [11]	12.00 [304.8]	2.46 [62.5]	9.90 [251.5]	HISP6-10
HIBSX-12SS-SS6-15KG	15 [33]	12.00 [304.8]	2.46 [62.5]	9.90 [251.5]	HISP6-20
HIBSX-12SS-SS6-45KG	45 [99]	12.00 [304.8]	2.46 [62.5]	9.90 [251.5]	HISP6-50
HIBSX-12SS-SS6-75KG	75 [165]	12.00 [304.8]	2.46 [62.5]	9.90 [251.5]	HISP6-100

REV.	ECO/DDC	DESCRIPTION	DATE	DRAFT	CHECK	APVD
A	---	RELEASED.	02-11-22	V.J.C.	J.M.	V.J.C.

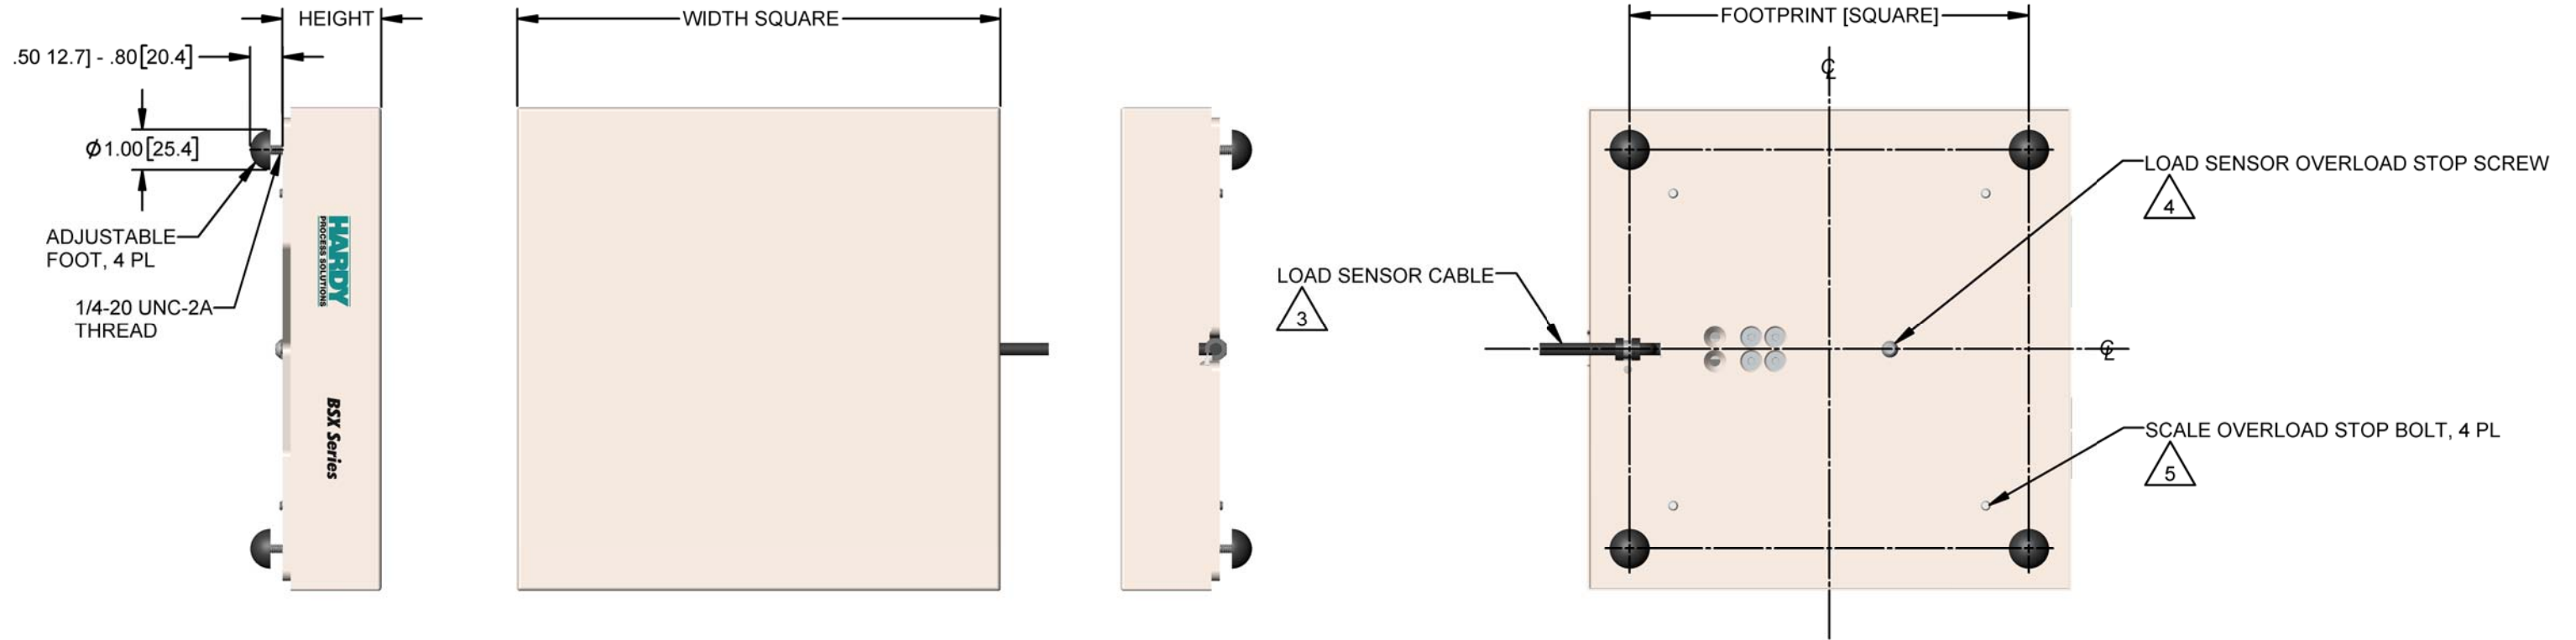

- 5 SEE HARDY PROCESS SOLUTIONS WEB SITE FOR SCALE OVERLOAD STOP BOLT SETTINGS.
- 4 SEE HARDY PROCESS SOLUTIONS WEB SITE FOR LOAD SENSOR OVERLOAD STOP SCREW SETTINGS .
- 3 CABLE TYPE: 6 CONDUCTOR, 24AWG, SHIELDED, WITH DRAIN WIRE
C2 FEATURE IS INSTALLED INSIDE THE LOAD SENSOR BODY
CABLE LENGTH: 10 FEET [3 METER]
CABLE JACKET: PVC
CABLE WIRE COLOR TERMINATIONS:

EXCITATION +	RED
EXCITATION -	BLACK
SIGNAL +	GREEN
SIGNAL -	WHITE
C2 +	GRAY
C2 -	VIOLET
SHIELD (DRAIN)	YELLOW (OR CLEAR)

- 2. SCALE MATERIAL IS TYPE 304 STAINLESS STEEL. SCALE LOAD SENSOR MATERIAL IS TYPE 17-4PH STAINLESS STEEL.
- 1. SEE HARDY PROCESS SOLUTIONS WEB SITE FOR ADDITIONAL INSTALLATION AND WIRING INFORMATION.

NOTES: UNLESS OTHERWISE SPECIFIED

PROPRIETARY NOTICE
ALL DATA AND INFORMATION CONTAINED IN OR DISCLOSED BY THIS DOCUMENT IS CONFIDENTIAL AND PROPRIETARY INFORMATION OF HARDY PROCESS SOLUTIONS AND ALL RIGHTS THEREIN ARE EXPRESSLY RESERVED. BY ACCEPTING THIS MATERIAL THE RECIPIENT AGREES THAT THIS MATERIAL AND THE INFORMATION CONTAINED THEREIN IS HELD IN CONFIDENCE AND IN TRUST AND SHALL NOT BE USED, COPIED, REPRODUCED IN WHOLE OR IN PART, NOR ITS CONTENTS REVEALED IN ANY MANNER TO OTHERS, EXCEPT TO MEET THE SPECIFIC PURPOSE FOR WHICH IT WAS DELIVERED.



HI BSX SS6 BENCH SCALE SERIES

ITEM	QTY	0588-0212	OUTLINE DRAWING, HI BSX SS6 SERIES BENCH SCALES	DESCRIPTION	COMMENTS
PARTS LIST					
UNLESS OTHERWISE SPECIFIED DIMENSIONS ARE IN INCHES [MM] TOLERANCES ARE: FRACTIONS: N/A DECIMALS: .XX = ±.03 [.76] .XXX = ±.010 [.25] ANGLES ±0°, 30°		CONTRACT NO.		<p>OUTLINE DRAWING, HI BSX SS6 SERIES BENCH SCALES</p>	
MATERIAL		APPROVALS			
FINISH		DRAWN V. CHULA			
DO NOT SCALE DRAWING		CHECKED J. MOEN			
		APPROVED V. CHULA		DATE 02-11-22	
		ISSUED V. CHULA		DATE 02-11-22	
		PRODUCTION		DATE	
SIZE	FSCM	DRAWING NO.		REV.	
D	21316	0588-0212		A	
FILE NAME:0588-0212A1.SLDDRW			SCALE: NONE	SHEET 1 OF 1	

