
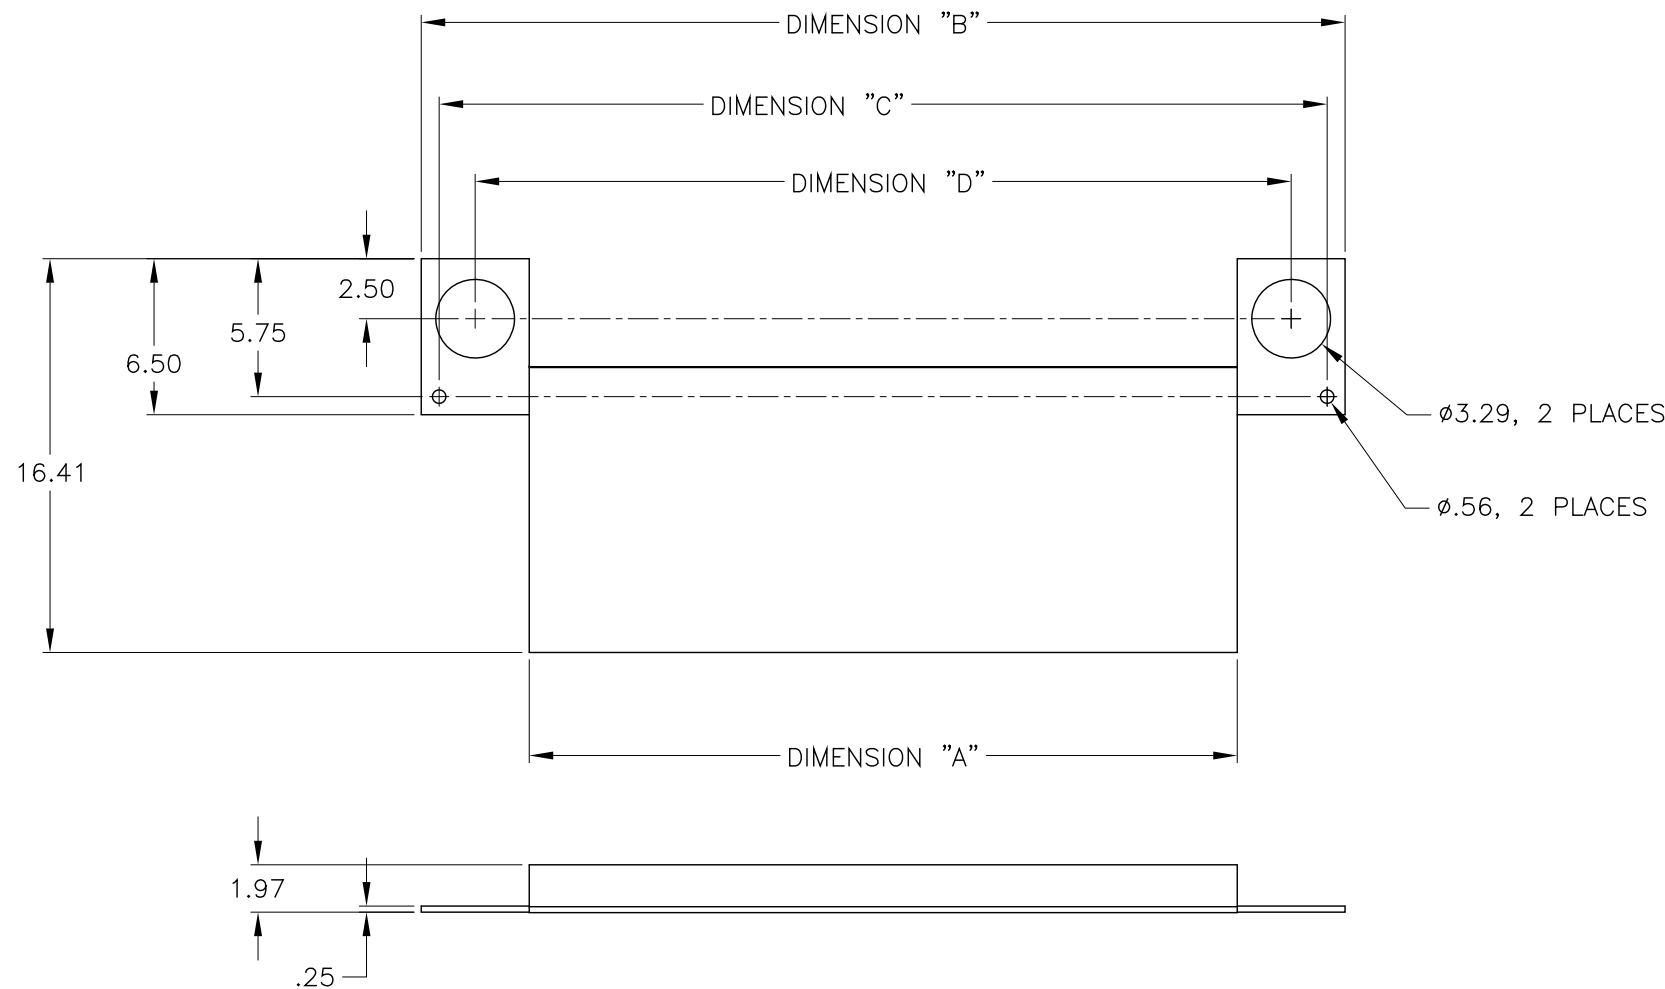


MODEL NUMBER CONFIGURATION CHART

MODEL NUMBER	RAMP MATERIAL	RAMP DECK TYPE	DIMENSION A	DIMENSION B	DIMENSION C	DIMENSION D
HIDSR-3012-PS-S	PAINTED STEEL	SMOOTH	29.5 IN	38.5 IN	37.0 IN	34.0 IN
HIDSR-3012-PS-T	PAINTED STEEL	TREAD	29.5 IN	38.5 IN	37.0 IN	34.0 IN
HIDSR-3012-SS-S	STAINLESS STEEL	SMOOTH	29.5 IN	38.5 IN	37.0 IN	34.0 IN
HIDSR-3012-SS-T	STAINLESS STEEL	TREAD	29.5 IN	38.5 IN	37.0 IN	34.0 IN
HIDSR-3612-PS-S	PAINTED STEEL	SMOOTH	35.5 IN	44.5 IN	43.0 IN	40.0 IN
HIDSR-3612-PS-T	PAINTED STEEL	TREAD	35.5 IN	44.5 IN	43.0 IN	40.0 IN
HIDSR-3612-SS-S	STAINLESS STEEL	SMOOTH	35.5 IN	44.5 IN	43.0 IN	40.0 IN
HIDSR-3612-SS-T	STAINLESS STEEL	TREAD	35.5 IN	44.5 IN	43.0 IN	40.0 IN

REV.	ECO/DDC	DESCRIPTION	DATE	DRAFT	CHECK	APV'D
A	----	RELEASED.	06-03-24	V.J.C.	J.M.	V.J.C.

 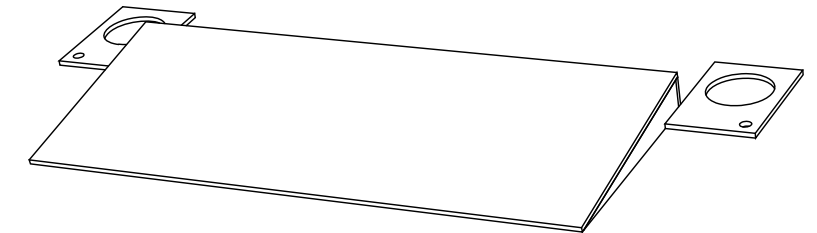


2. SEE HARDY PROCESS SOLUTIONS WEB SITE FOR ADDITIONAL INFORMATION.

1. THIS DRAWING IS SUBJECT TO CHANGE WITHOUT NOTICE.

NOTES: UNLESS OTHERWISE SPECIFIED

PROPRIETARY NOTICE
 ALL DATA AND INFORMATION CONTAINED IN OR DISCLOSED BY THIS DOCUMENT IS CONFIDENTIAL AND PROPRIETARY INFORMATION OF HARDY PROCESS SOLUTIONS INC. AND ALL RIGHTS THEREIN ARE EXPRESSLY RESERVED. BY ACCEPTING THIS MATERIAL THE RECIPIENT AGREES THAT THIS MATERIAL AND THE INFORMATION CONTAINED THEREIN IS HELD IN CONFIDENCE AND IN TRUST AND SHALL NOT BE USED, COPIED, REPRODUCED IN WHOLE OR IN PART, NOR ITS CONTENTS REVEALED IN ANY MANNER TO OTHERS, EXCEPT TO MEET THE SPECIFIC PURPOSE FOR WHICH IT WAS DELIVERED.



ITEM	QTY	PART NUMBER	DESCRIPTION	COMMENTS
PARTS LIST				
UNLESS OTHERWISE SPECIFIED DIMENSIONS ARE IN INCHES		CONTRACT NO. 0588-0228		
TOLERANCES ARE:		APPROVALS		
FRACTIONS: N/A		DRAWN V. CHULA DATE 05-20-24		
DECIMALS: .X = ±.1		CHECKED J. MOEN DATE 05-30-24		
.XX = ±.03		APPROVED V. CHULA DATE 06-03-24		
ANGLES: ±0°, 30°		ISSUED V. CHULA DATE 06-03-24		
MATERIAL		PRODUCTION DATE		
FINISH		DO NOT SCALE DRAWING		
TITLE		DRAWING NO.		
HARDY PROCESS SOLUTIONS		OUTLINE DRAWING, HIDSR SERIES DRUM SCALE RAMPS		
		SIZE	FSCM	REV.
D 21316		0588-0228		A
FILE NAME: 588228A1.DWG		SCALE: NONE		SHEET 1 OF 1