

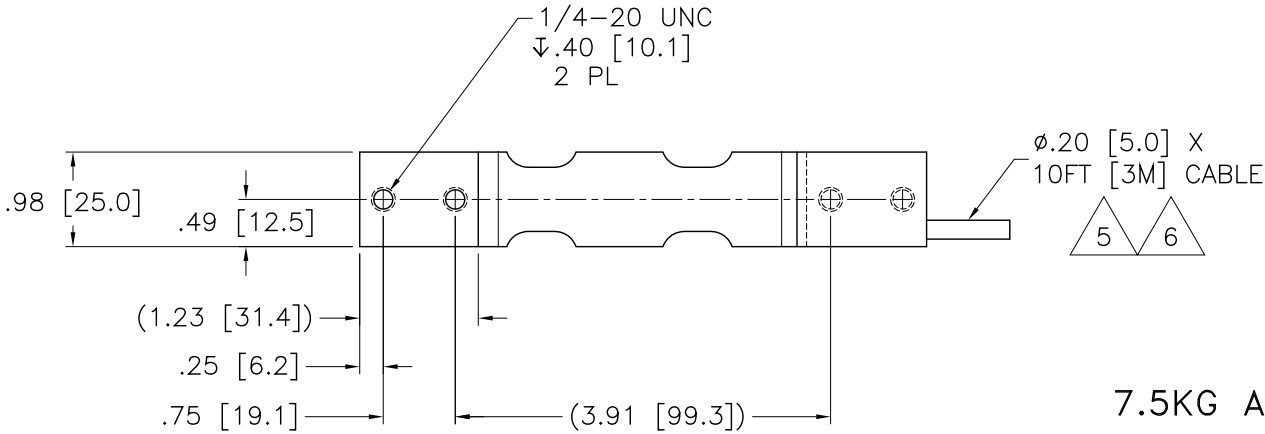


CAPACITY KG	MODEL NUMBER
7.5	HISP1-7.5
10	HISP1-10
15	HISP1-15
30	HISP1-30
50	HISP1-50
75	HISP1-75
100	HISP1-100
200	HISP1-200

REV.	ECO/DDC	DESCRIPTION	DATE	DRAFT	CHECK	APV'D
A	----	RELEASED.	07-28-04	S.N.	T.K.	S.N.
B	10245	REVISED PER ECN.	08-16-07	T.N.	S.N.	V.J.C.
C	10675	REVISED PER ECN.	09-23-09	V.J.C.	C.B.	V.J.C.
D	----	ADDED THREAD DIMENSION FOR 7.5KG-100KG MODELS.	07-12-23	V.J.C.	J.M.	V.J.C.

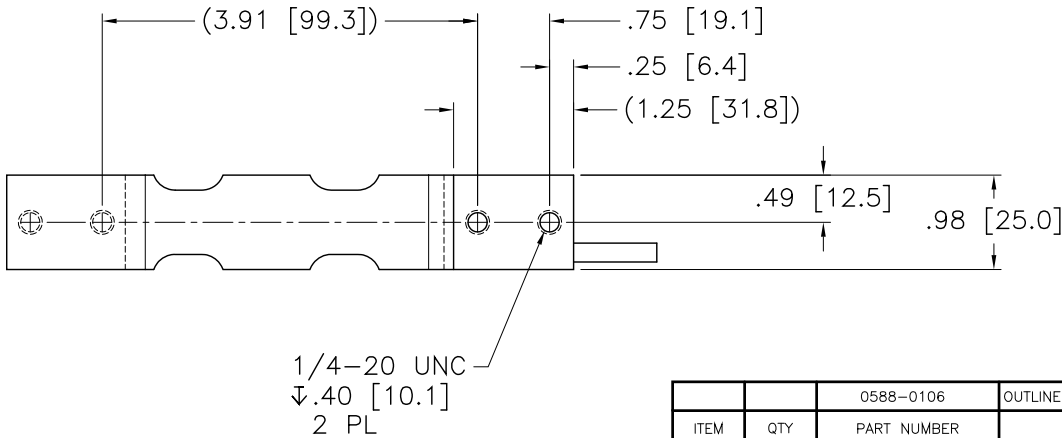

7.5KG AND 10KG

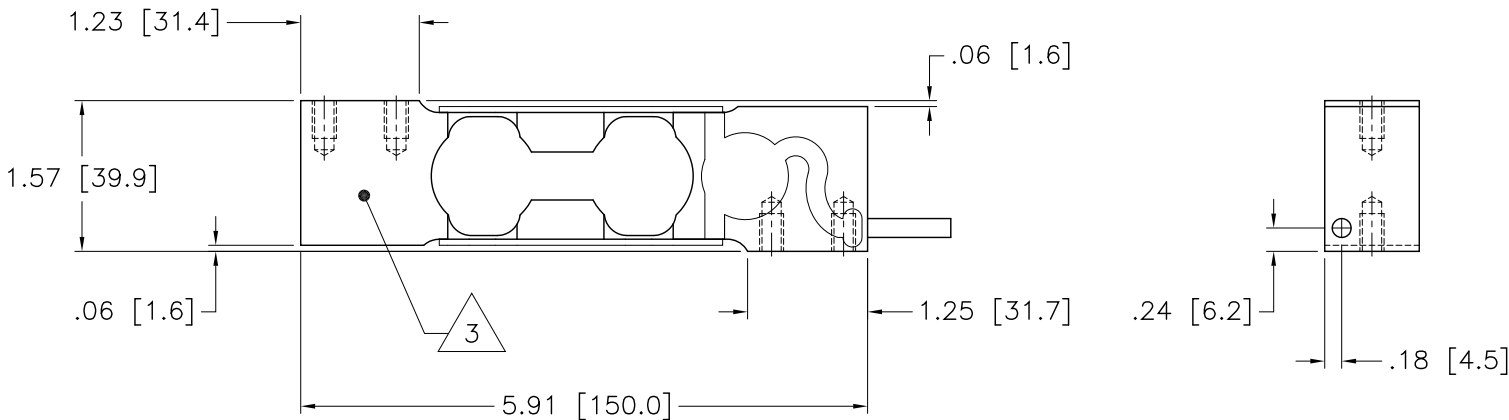

9. THIS DRAWING IS SUBJECT TO CHANGE WITHOUT NOTICE.
8. SEE SHEET 2 FOR 15 KG THROUGH 200KG DIMENSIONS.
7. CABLE IS 6 CONDUCTOR, SHIELDED AND 10FT [3M] IN LENGTH. CABLE SHIELD IS FLOATING.

6 NOMINAL EXTERNAL C2 MODULE DIMENSIONS: Ø.50 [12.7] X 1.40 [36.0]. C2 MODULE IS LOCATED ON THE CABLE END OF THE LOAD SENSOR.

5 WIRE COLOR CODE:

EXCITATION +	GREEN
EXCITATION -	BLACK
SIGNAL +	WHITE
SIGNAL -	RED
SHIELD	YELLOW
C2 +	GRAY
C2 -	VIOLET

4. CABLE WIRE ENDS ARE STRIPPED BACK 0.5 IN. AND TINNED. CABLE JACKET IS STRIPPED BACK APPROX. 5 IN.

3 LOCATION OF SERIAL NUMBER LABEL.








2. MATERIAL: SENSOR BODY - STAINLESS STEEL 17.4PH (1.4548).

1. RATED OUTPUT: 2mV/V ±5%

NOTES: UNLESS OTHERWISE SPECIFIED

PROPRIETARY NOTICE
ALL DATA AND INFORMATION CONTAINED IN OR DISCLOSED BY THIS DOCUMENT IS CONFIDENTIAL AND PROPRIETARY INFORMATION OF HARDY PROCESS SOLUTIONS INC. AND ALL RIGHTS THEREIN ARE EXPRESSLY RESERVED. BY ACCEPTING THIS MATERIAL THE RECIPIENT AGREES THAT THIS MATERIAL AND THE INFORMATION CONTAINED THEREIN IS HELD IN CONFIDENCE AND IN TRUST AND SHALL NOT BE USED, COPIED, REPRODUCED IN WHOLE OR IN PART, NOR ITS CONTENTS REVEALED IN ANY MANNER TO OTHERS, EXCEPT TO MEET THE SPECIFIC PURPOSE FOR WHICH IT WAS DELIVERED.

		0588-0106	OUTLINE DRAWING, LOAD SENSOR, HISP1 SERIES	MATERIAL OR COMMENTS	
ITEM	QTY	PART NUMBER	DESCRIPTION		COMMENTS
PARTS LIST					
UNLESS OTHERWISE SPECIFIED DIMENSIONS ARE IN INCHES [MM] TOLERANCES ARE: DECIMALS: .XX = ±.03 [.8] .XXX = ±.010 [.25] ANGLES: ±0°, 30'		CONTRACT NO.		 TITLE OUTLINE DRAWING, LOAD SENSOR, HISP1 SERIES	
		APPROVALS			
		DRAWN S. NAVARRO	DATE 07-22-04		
		CHECKED T. KOPCZYNSKI	DATE 07-28-04		
MATERIAL		APPROVED S. NAVARRO	DATE 07-28-04	SIZE FSCM DRAWING NO. REV. D 21316 0588-0106 D	
FINISH		ISSUED S. NAVARRO	DATE 07-28-04		
DO NOT SCALE DRAWING		PRODUCTION	DATE		
		FILE NAME: 588106D1.DWG		SCALE: NONE	SHEET 1 OF 2

 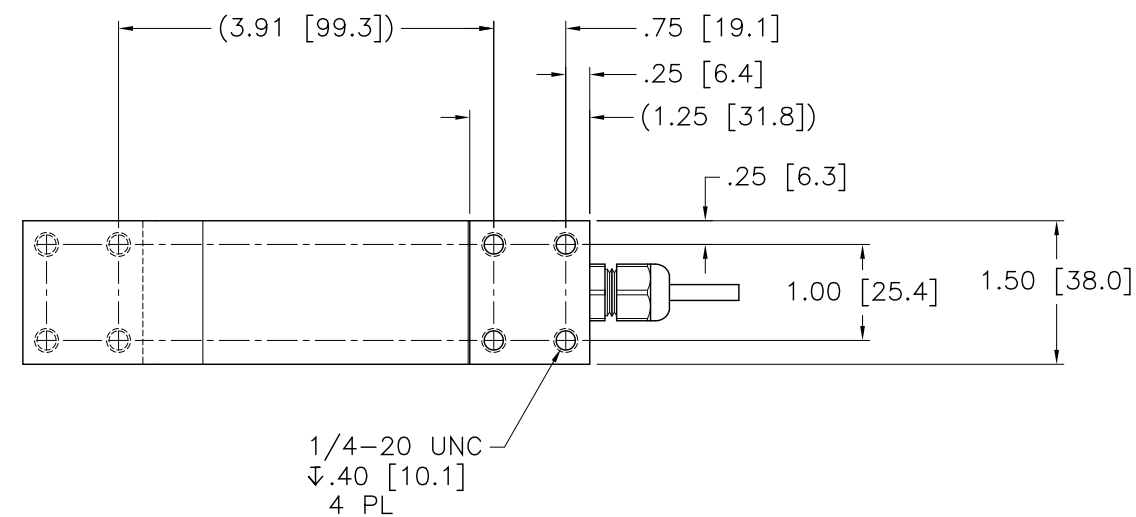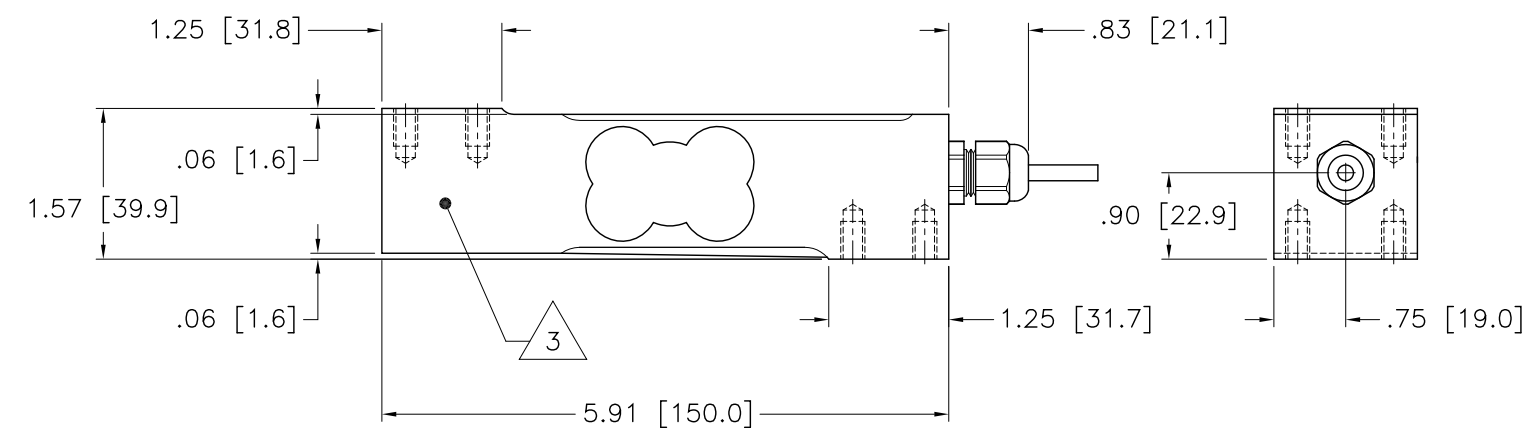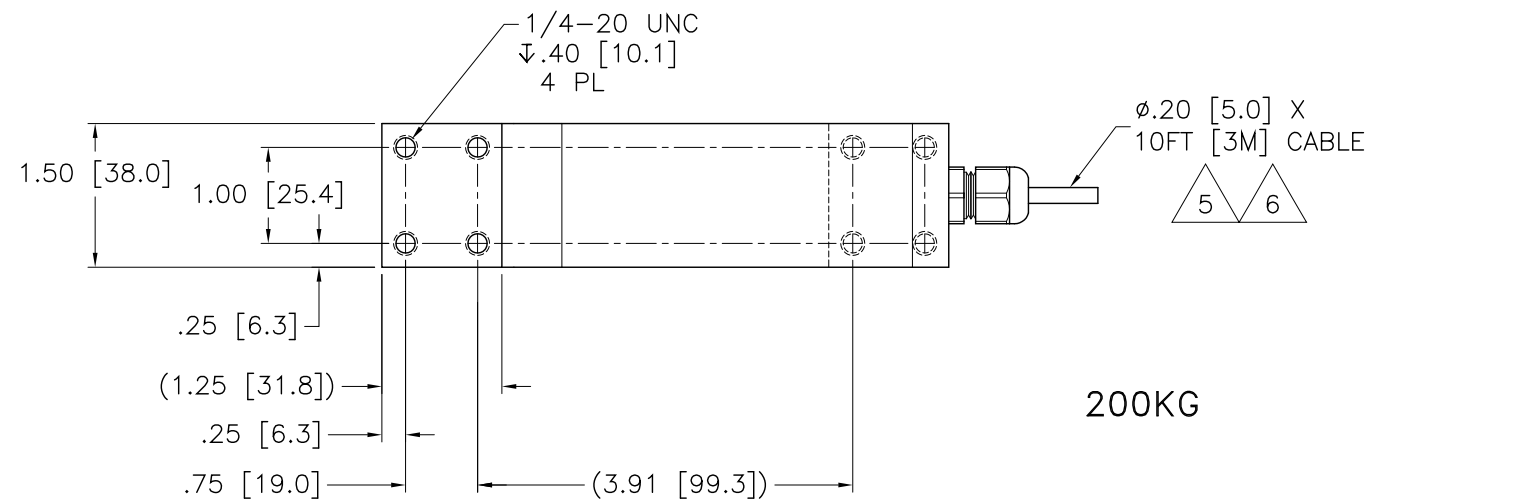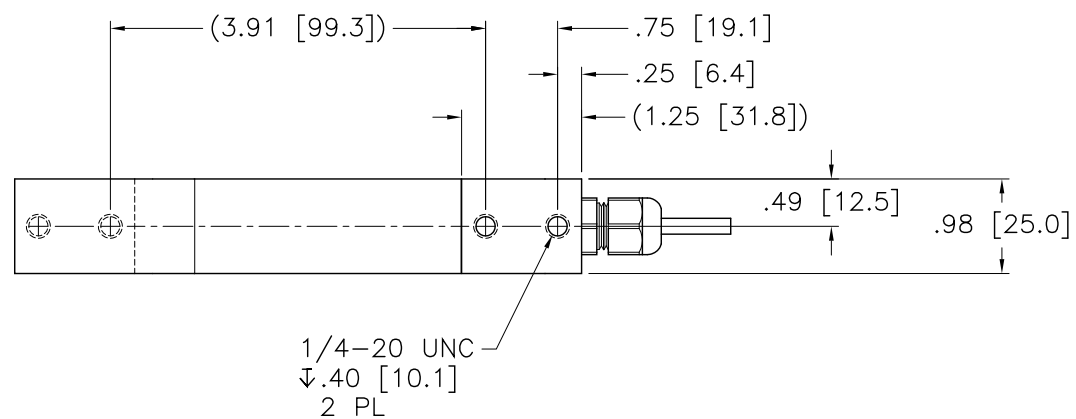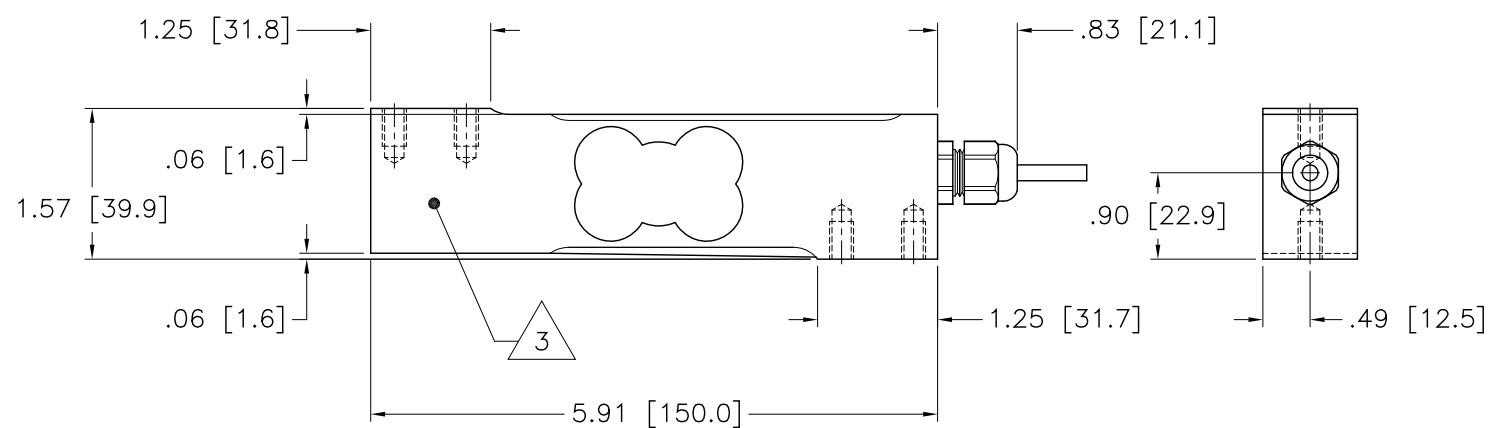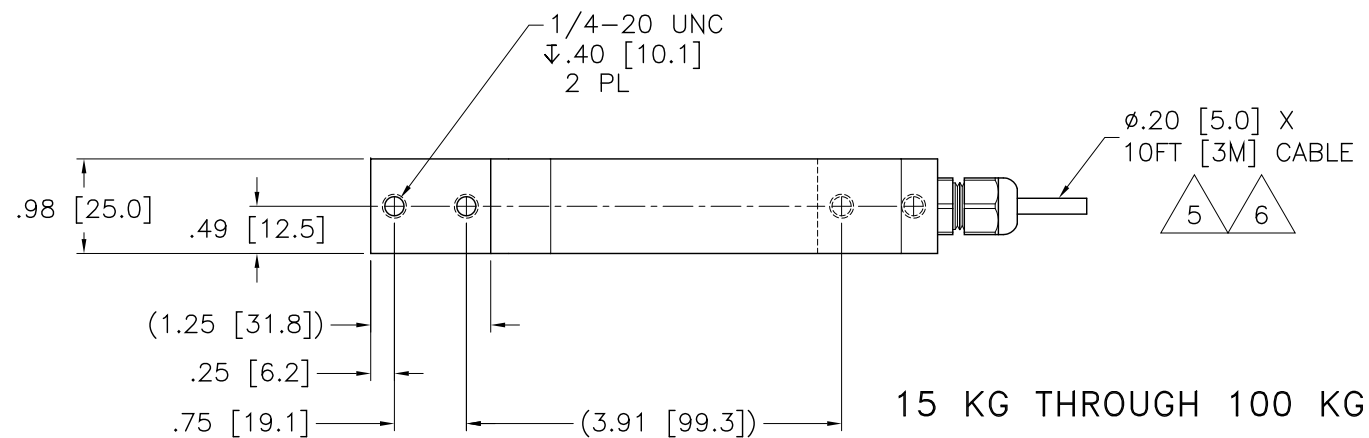

HARDY PROCESS SOLUTIONS				
TITLE				
OUTLINE DRAWING, LOAD SENSOR, HISP1 SERIES				
SIZE	FSCM	DRAWING NO.		REV.
D	21316	0588-0106		D
FILE NAME:		588106D1.DWG	SCALE: NONE	SHEET 2 OF 2